



*Where lives blossom*

# Canterbury Court

DESIGNER IDENTIFICATION:

GE BAI

SCAD  
1600 Peachtree Rd NW,  
Atlanta, GA 30309

PHONE: 404-719-0885  
E-MAIL: gebai20@student.scad.edu

PROJECT IDENTIFICATION:

CANTERBURY  
COURT

3750 Peachtree Rd NE,  
Atlanta, GA 30319



CLIENT IDENTIFICATION:


Mr./Mrs. Kapoor

Canterbury Court  
End Unit Apartment

PROJECT AREA:	Residential Unit
DRAWN BY:	Ge Bai
CHECKED BY:	Prof. Challie Schafer
DATE:	May 20, 2020

COURSE #:	INDS 714-A02
COURSE NAME:	Grad Interior Design Studio II
PROFESSOR:	Prof. Challie Schafer
QUARTER:	SPRING 2020

DESIGN AREA:

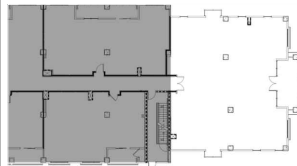

PROJECT NAME: Senior Living Assisted Living Unit  
SHEET SIZE: 11" x 17"


PLAN NORTH:









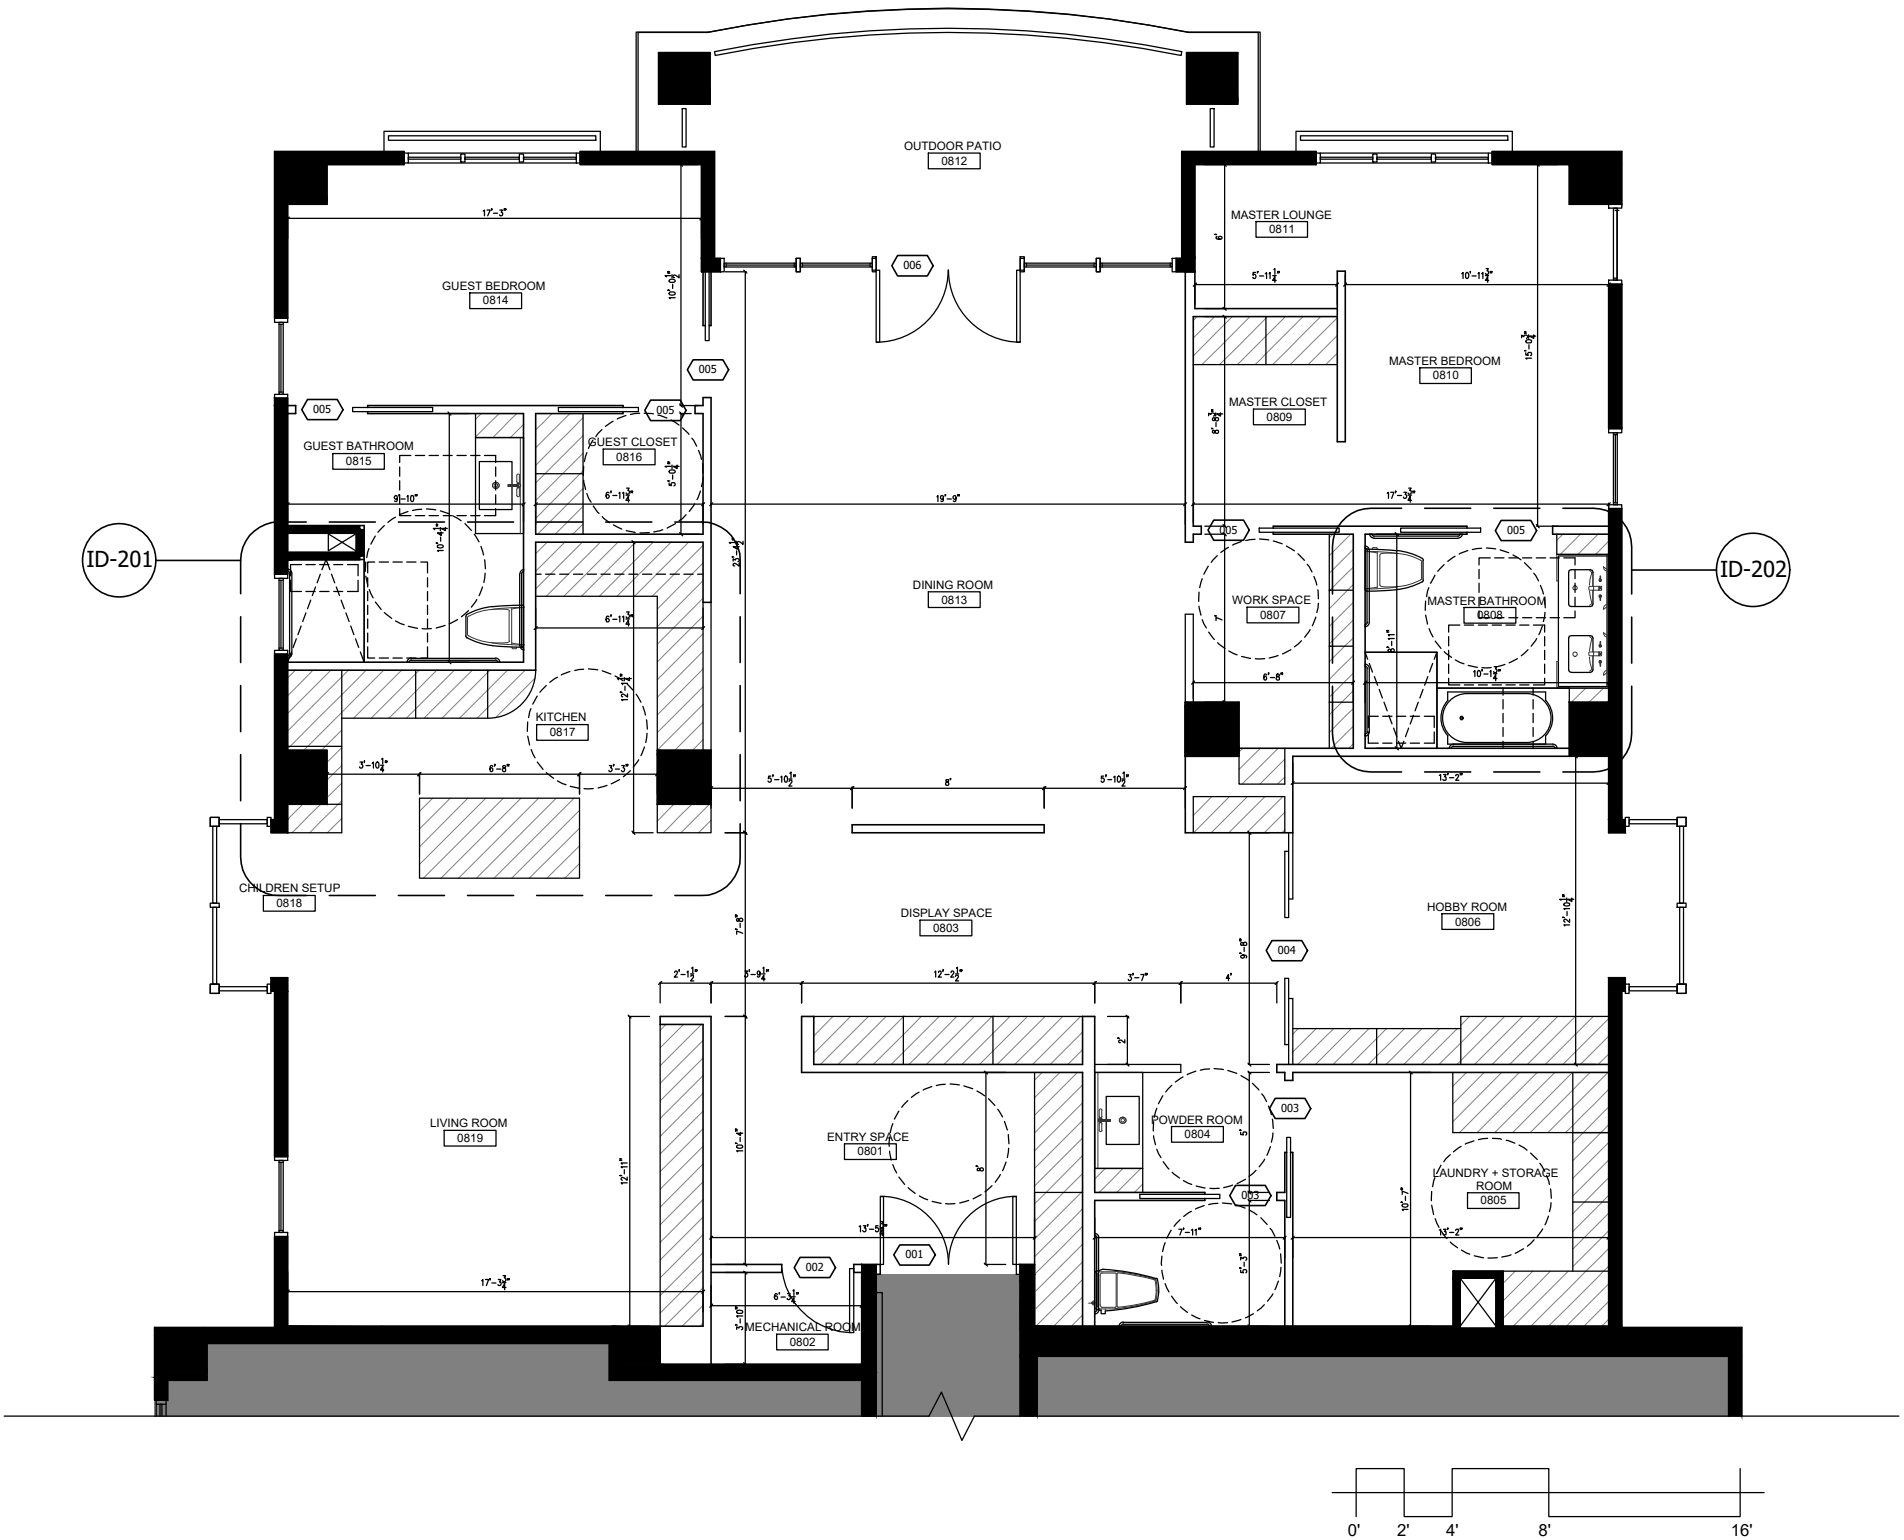

PLAN LEGEND

	EXISTING CONSTRUCTION
	N.I.C.
	NEW CONSTRUCTION
	MILL WORK

GENERAL NOTES

1. Refer to ID-001 graphic symbols.
2. Refer to ID-001 door and frame schedule.
3. All door frame are to be placed 4" perpendicular from adjacent partition unless noted otherwise.
4. Dimensions are from the finished face of partition to the finished face of partition.
5. Provide a level 5 finish in all areas where wall covering occur. Prefer to finish plan for wall covering location.
6. Coordinate with furniture vendor for blocking requirements.
7. Kitchen and master bathroom dimension detail refer to ID-201, ID-202.

DESIGNER IDENTIFICATION:

GE BAI

SCAD  
1600 Peachtree Rd NW,  
Atlanta, GA 30309

PHONE: 404-719-0885  
E-MAIL: gebai20@student.scad.edu

PROJECT IDENTIFICATION:

CANTERBURY  
COURT

3750 Peachtree Rd NE,  
Atlanta, GA 30319

CLIENT IDENTIFICATION:


Mr./Mrs. Kapoor

Canterbury Court  
End Unit Apartment

PROJECT AREA:	Residential Unit
DRAWN BY:	Ge Bai
CHECKED BY:	Prof. Challie Schafer
DATE:	May 20, 2020

COURSE #:	INDS 714-A02
COURSE NAME:	Grad Interior Design Studio II
PROFESSOR:	Prof. Challie Schafer
QUARTER:	SPRING 2020

KEY PLAN:

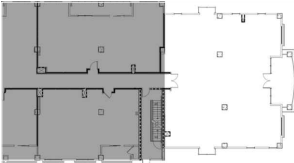


PROJECT NAME: Senior Living Assisted Living Unit  
SHEET SIZE: 11" x 17"  
SHEET SCALE: 1/8"=1'-0"  
SHEET TITLE: FLOOR PLAN

PLAN NORTH:



ID-101



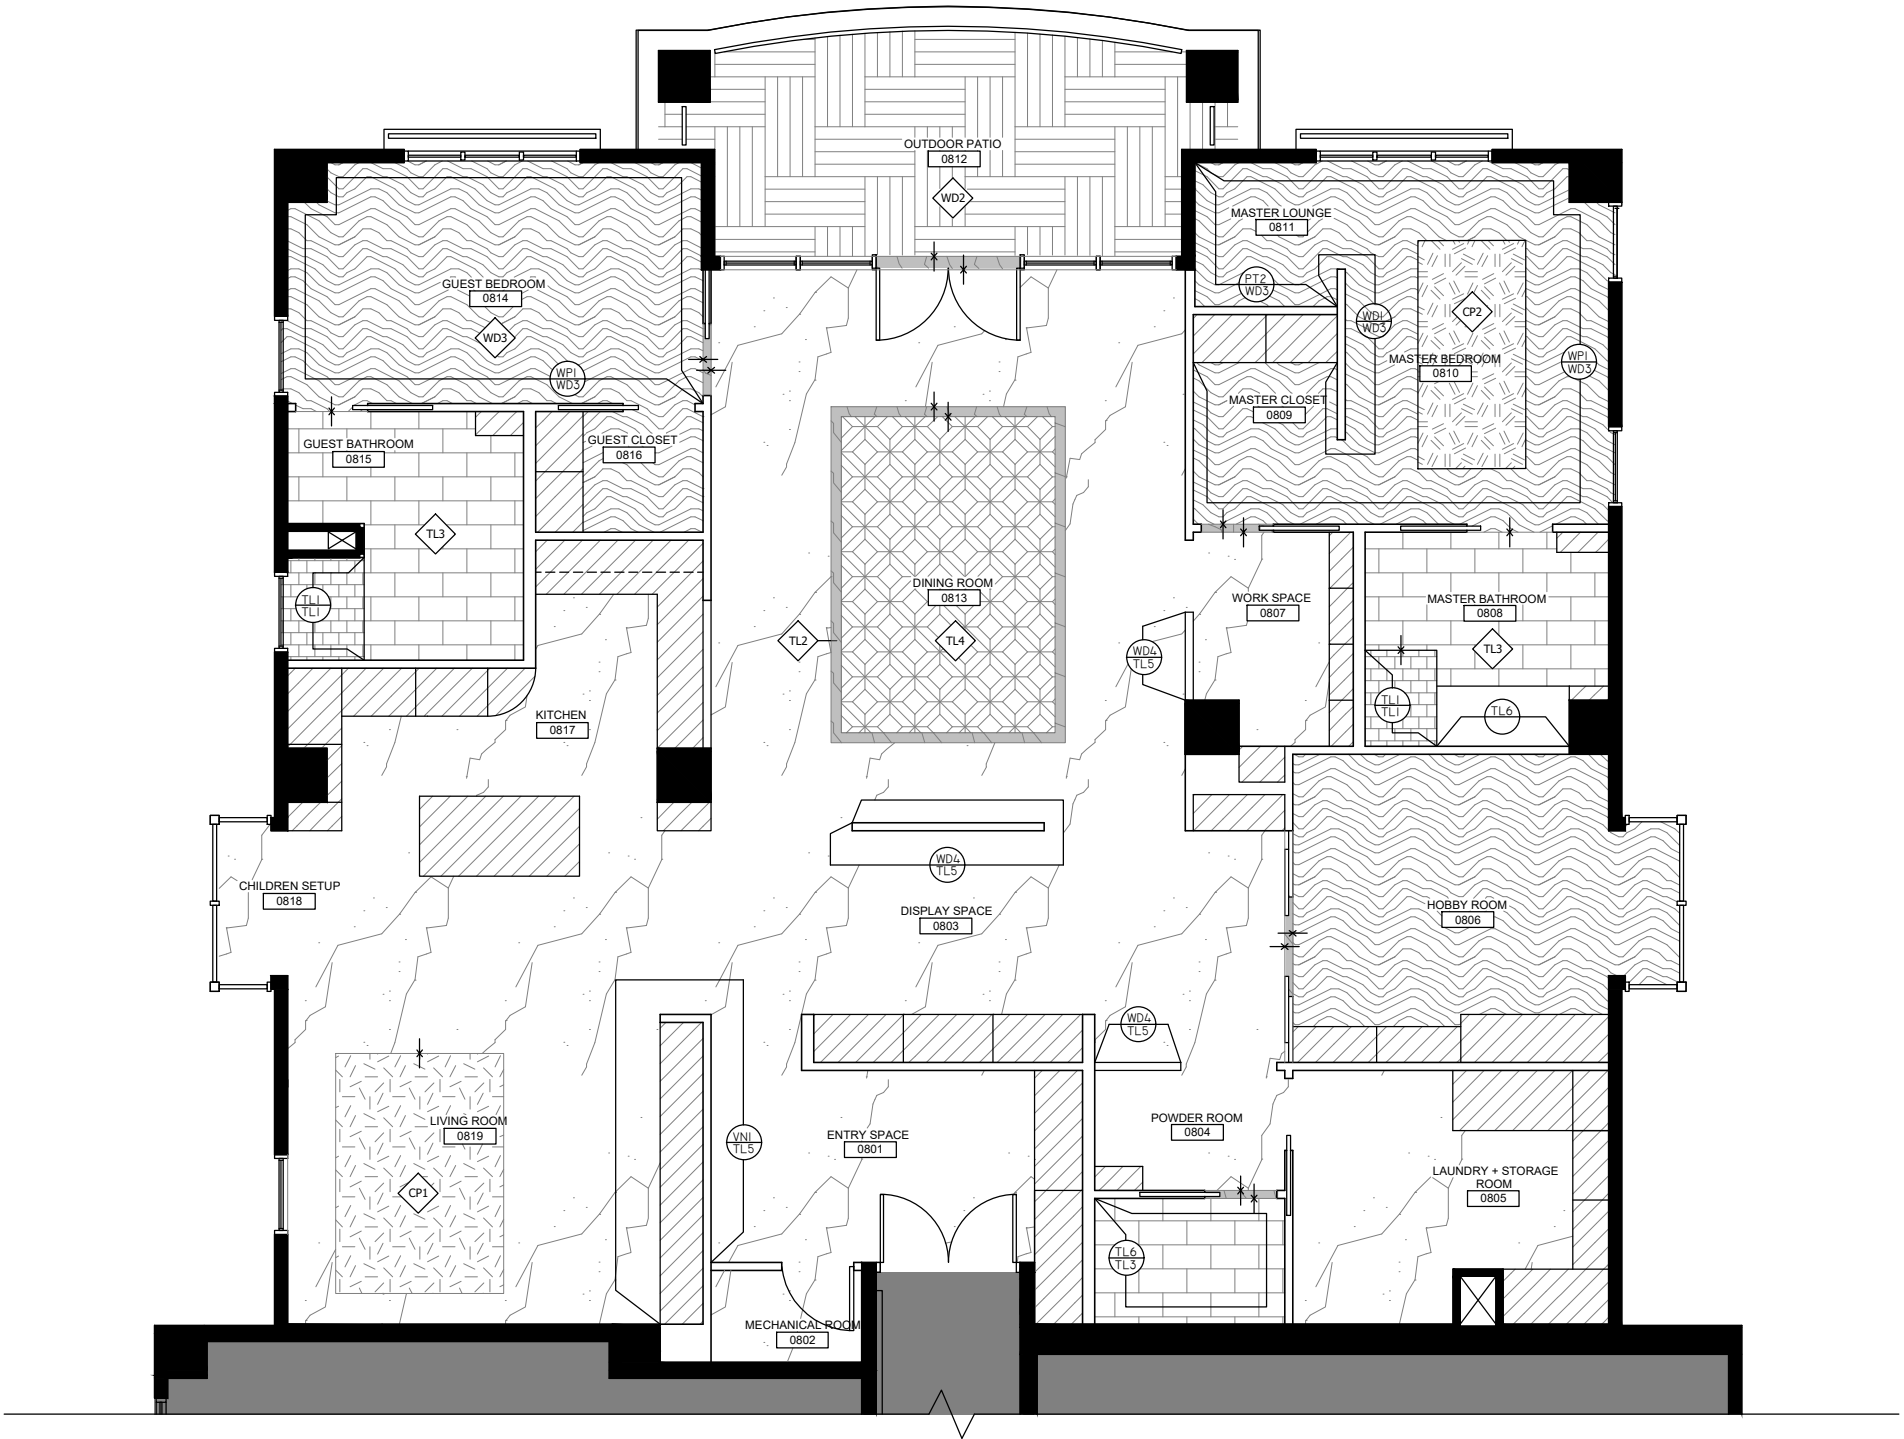

GENERAL NOTES

1. Refer to ID-001 graphic symbols.
2. Kitchen & Master Bathroom wall finishes refer to ID-301, ID-302, ID-303.
5. Provide a level 5 finish in all areas where wall covering occur. Refer to finish plan for wall covering location.
6. Tile start point and grout alignments to match finish plans.
7. Rugs to be inserted and the height to be aligned with the around flooring.
8. All baseboard finishes to be WD1 9" as per ADA compliancy unless noted otherwise.
9. All walls to be PT1 unless noted otherwise.
10. All flooring tile beneath doors to be TL2 unless noted otherwise.
11. Coordinate with furniture vendor for blocking requirements.

FLOOR FINISH LEGEND

	CP1		TL4
	CP2		TL5
	TL1		WD2
	TL2		WD3
	TL3		

PLAN LEGEND

	EXISTING CONSTRUCTION
	N.I.C.
	NEW CONSTRUCTION
	MILL WORK

FINISH SCHEDULE

FLOORING

CP1   CARPET Manufacture: Well Woven Product Number: XTBS1306 Color Name: Crimson/Red	TL4   TILE Manufacture: Elegantis Product Number: Geometry III Color Name: Light Bardiglio/ Bianco Carrera/ Oxford Beige/ Oxford Grey/ Arctic White
CP2   CARPET Manufacture: All Modern Product Number: A000691322 Color Name: Red/ Beige/ Blue	TL5   TILE Manufacture: Emser Product Number: 304372203 Color Name: Kalta Fiore
TL1   TILE Manufacture: Elite Tile Product Number: OVS1063 Color Name: Orange	WD2   WOOD Manufacture: IKEA Product Number: 902.342.26 Color Name: Brown Stained
TL2   TILE Manufacture: Floor Decor Product Number: 100198886 Color Name: Gray	WD3   WOOD Manufacture: British Hardwoods Profile: Tongue and Groove Species: American Black Walnut
TL3   TILE Manufacture: Floor Decor Product Number: 100572437 Color Name: White	

WALLS

TL1   TILE Manufacture: Elite Tile Product Number: OVS1063 Color Name: Orange	WD1   WOOD Manufacture: British Hardwoods Profile Style: Scotia Species: American Black Walnut
TL6   TILE Manufacture: Daltile Product Number: 302575146 Color Name: Bright White	WD4   WOOD Manufacture: Lightwave Laser Pattern: Custom Panels Finishing: Walnut
PT1   PAINT Manufacture: Sherwin-Williams Product Number: SW7004 Color Name: Snowbound	VN1   VENEER Manufacture: Boleform Product Number: 1208093 Material: Walnut
PT2   PAINT Manufacture: Sherwin-Williams Product Number: SW6475 Color Name: Country Squire	WP1   WALLPAPER Manufacture: Warner Textures Product Number: BREW1748 Material: Cream

DESIGNER IDENTIFICATION:

GE BAI

SCAD  
1600 Peachtree Rd NW,  
Atlanta, GA 30309

PHONE: 404-719-0885  
E-MAIL: gebai20@student.scad.edu

PROJECT IDENTIFICATION:

CANTERBURY  
COURT

3750 Peachtree Rd NE,  
Atlanta, GA 30319

CLIENT IDENTIFICATION:

Mr./Mrs. Kapoor

Canterbury Court  
End Unit Apartment

PROJECT AREA: Residential Unit

DRAWN BY: Ge Bai

CHECKED BY: Prof. Challie Schafer

DATE: May 20, 2020


COURSE #: INDS 714-A02

COURSE NAME: Grad Interior Design Studio II

PROFESSOR: Prof. Challie Schafer

QUARTER: SPRING 2020

KEY PLAN:

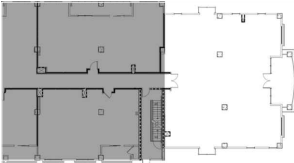

PROJECT NAME: Senior Living Assisted Living Unit

SHEET SIZE: 11" x 17"

SHEET SCALE: 1/8"=1'-0"


SHEET TITLE: FINISH PLAN

PLAN NORTH:



ID-102



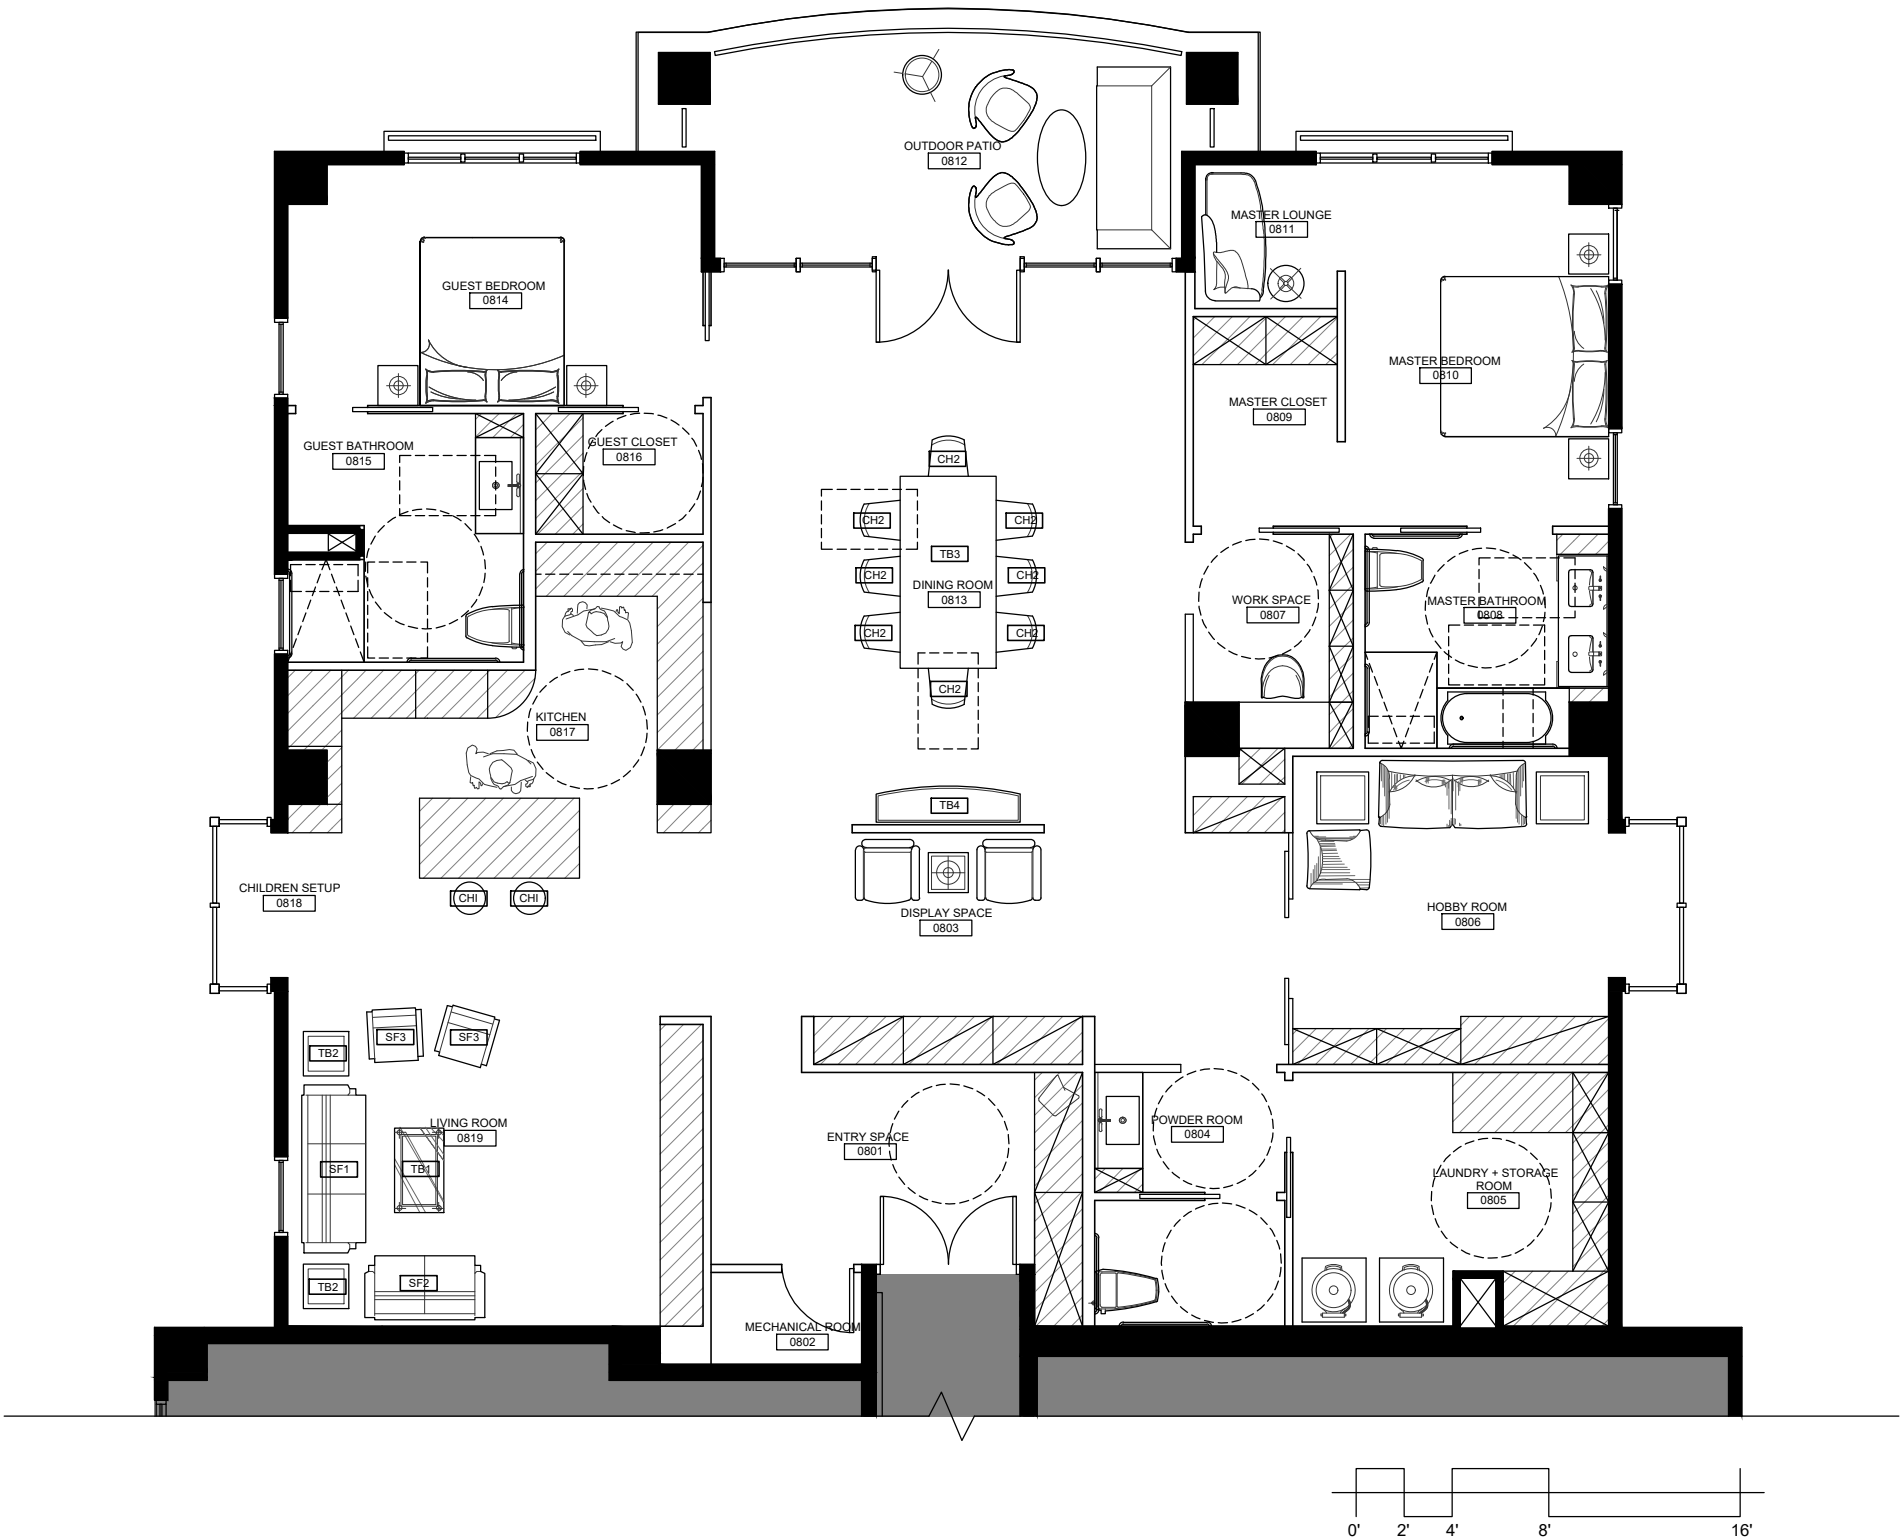

PLAN LEGEND

	EXISTING CONSTRUCTION
	N.I.C.
	NEW CONSTRUCTION
	MILL WORK

GENERAL NOTES

1. Refer to ID-001 graphic symbols.
2. Refer to ID-001 furniture schedule.
3. Furniture is shown for preference only.

DESIGNER IDENTIFICATION:

GE BAI

SCAD  
1600 Peachtree Rd NW,  
Atlanta, GA 30309

PHONE: 404-719-0885  
E-MAIL: gebai20@student.scad.edu

PROJECT IDENTIFICATION:

CANTERBURY  
COURT

3750 Peachtree Rd NE,  
Atlanta, GA 30319

CLIENT IDENTIFICATION:


Mr./Mrs. Kapoor

Canterbury Court  
End Unit Apartment

PROJECT AREA:	Residential Unit
DRAWN BY:	Ge Bai
CHECKED BY:	Prof. Challie Schafer
DATE:	May 20, 2020

COURSE #:	INDS 714-A02
COURSE NAME:	Grad Interior Design Studio II
PROFESSOR:	Prof. Challie Schafer
QUARTER:	SPRING 2020

KEY PLAN:

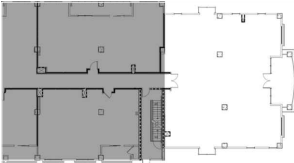

PROJECT NAME: Senior Living Assisted Living Unit  
SHEET SIZE: 11" x 17"  
SHEET SCALE: 1/8"=1'-0"  
SHEET TITLE: FURNITURE PLAN

PLAN NORTH:



ID-103



GENERAL NOTES

1. Refer to ID-001 graphic symbols.
2. Refer to ID-001 lighting fixture schedule.
3. All ceiling finish to be gypsum board at 9'-3" AFF unless noted otherwise.
4. All gypsum board ceiling to be painted as PT3 (refer to ID-001 wall schedule) unless mentioned otherwise.
5. Align the door window frame at 84" AFF.
6. Coordinate with furniture vendor for under cabinet lighting.
7. Dimensions are from the finished face of partition to the center of the light fixture.
8. All center lines are shown with respect to light fixtures and ceilings.
9. All faux wood ceiling tiles at outdoor patio to be 6" width.
10. All faux wood ceiling tiles at master suite, guest suite, and hobby room to be 9" width, mount begin from door side.

LIGHT FIXTURE SCHEDULE

TAG	SYMBOL	TYPE OF LIGHT
A		PENDANT / CHANDELIER
B		PENDANT / CHANDELIER
C		PENDANT / CHANDELIER
D		2" RECESSED TRACK LIGHTS
E		4" RECESSED LED DOWNLIGHT
F		RECESSED STRIP LIGHT
G		WALL SCONCE
H		WALL SCONCE
K		BOWL CEILING LIGHT

CEILING FINISH LEGEND

HR		HEMP ROPE
FW		FAUX WOOD CEILING TILES
FG		FROST GLASS
FA		FABRIC ARTWORK

PLAN LEGEND

	EXISTING CONSTRUCTION
	N.I.C.
	NEW CONSTRUCTION
	MILL WORK

DESIGNER IDENTIFICATION:

GE BAI

SCAD  
1600 Peachtree Rd NW,  
Atlanta, GA 30309

PHONE: 404-719-0885  
E-MAIL: gebai20@student.scad.edu

PROJECT IDENTIFICATION:

CANTERBURY  
COURT

3750 Peachtree Rd NE,  
Atlanta, GA 30319

CLIENT IDENTIFICATION:

Mr./Mrs. Kapoor

Canterbury Court  
End Unit Apartment

PROJECT AREA: Residential Unit  
DRAWN BY: Ge Bai  
CHECKED BY: Prof. Chalie Schafer  
DATE: May 20, 2020

COURSE #: INDS 714-A02  
COURSE NAME: Grad Interior Design Studio II  
PROFESSOR: Prof. Chalie Schafer  
QUARTER: SPRING 2020


KEY PLAN:

PROJECT NAME: Senior Living Assisted Living Unit  
SHEET SIZE: 11" x 17"  
SHEET SCALE: 1/8"=1'-0"  
SHEET TITLE: REFLECTED CEILING PLAN

PLAN NORTH:



ID-104

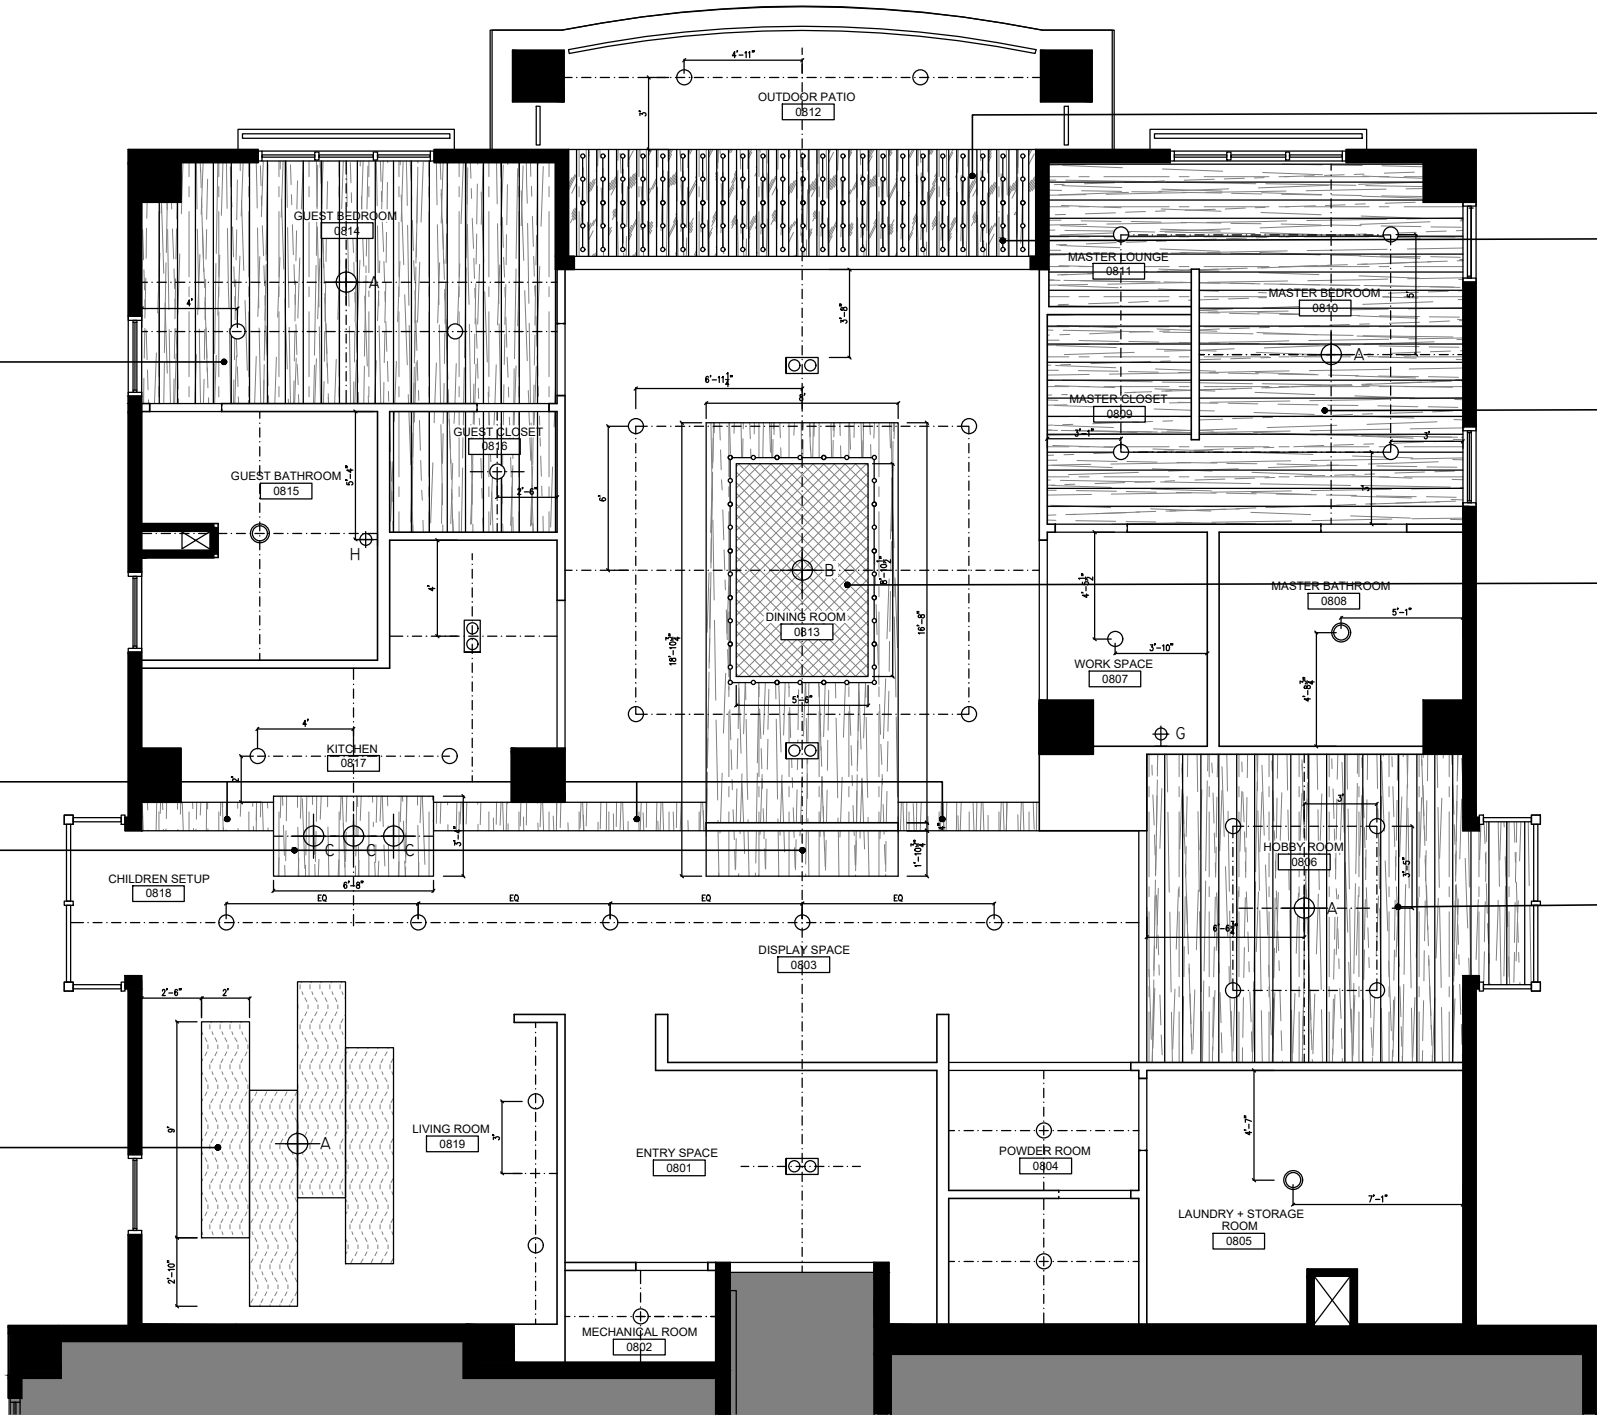

FG 9'-3"

FW 9'-3"

FW 9'-3"

HR 8'-4"

FW 9'-3"


FW 9'-3"

FW 8'-9"

HR 8'-4"

FW 8'-4"



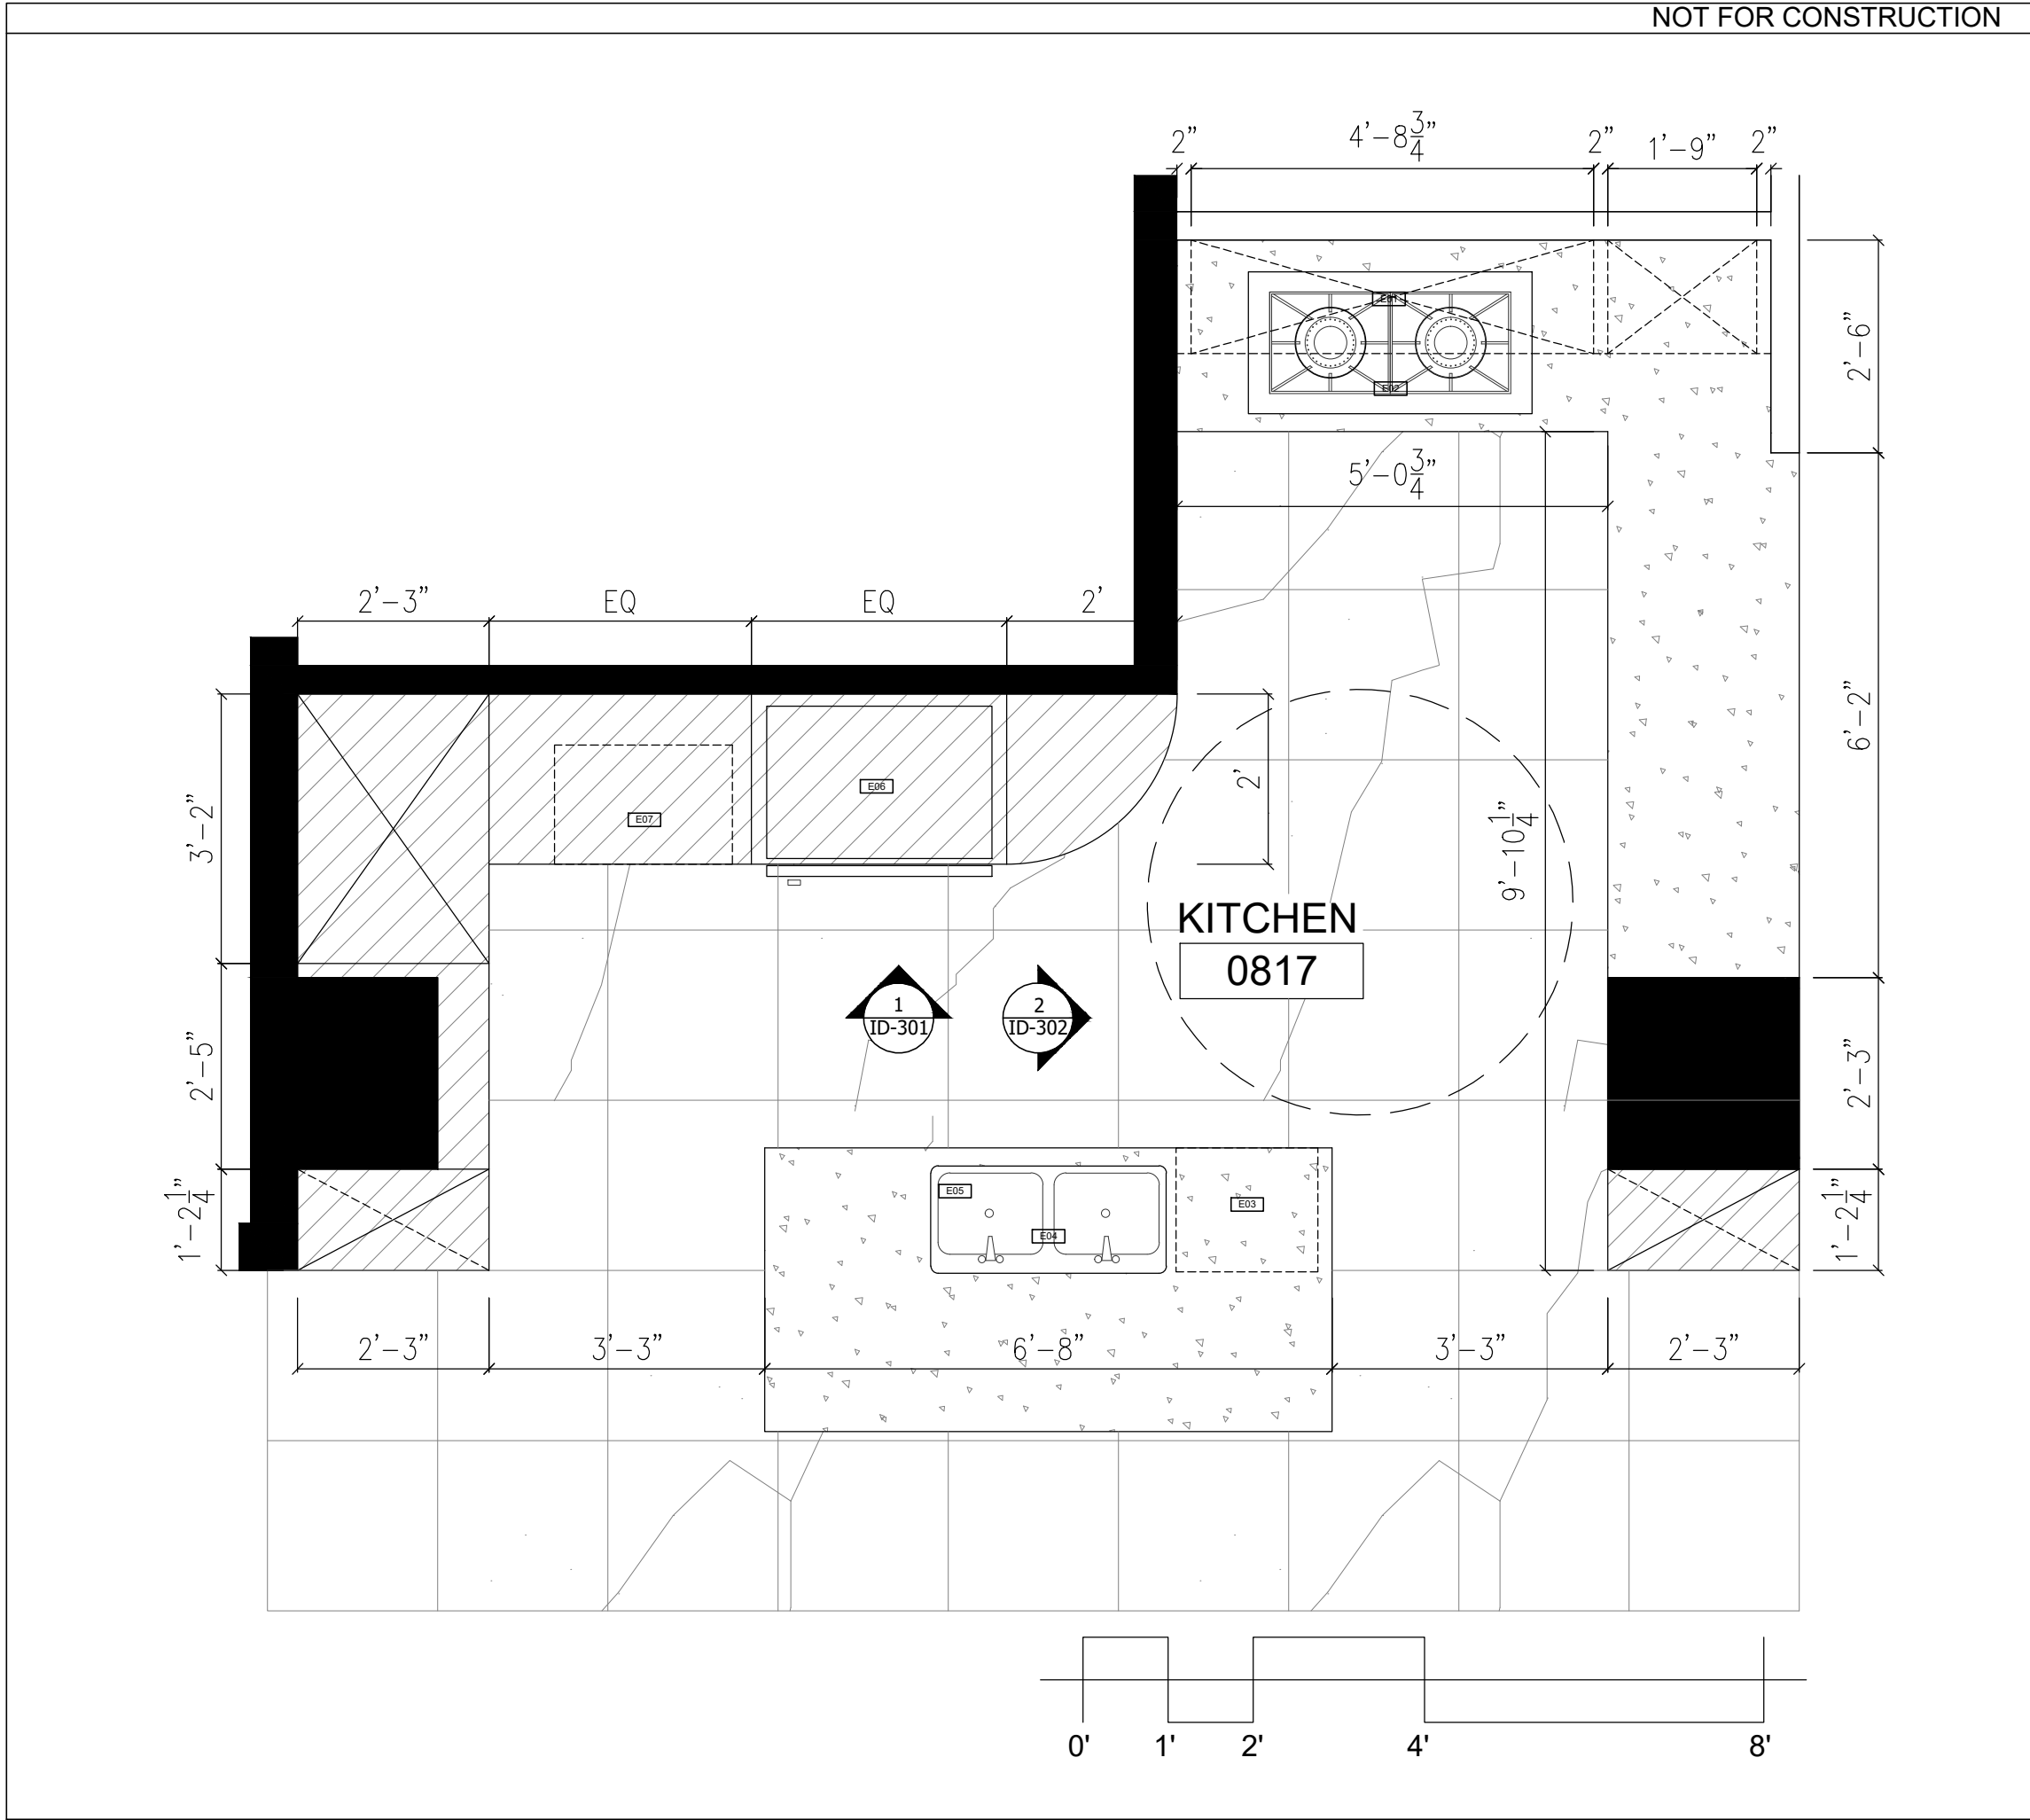

GENERAL NOTES	
<div>1. Refer to ID-001 graphic symbols.</div> <div>2. Refer to ID-001 equipment schedule.</div> <div>3. Refer to ID-001 flooring schedule.</div> <div>4. All flooring tile to be 24"x24" unless mentioned otherwise.</div> <div>5. Refer to ID-301, ID-302.</div>	
FLOOR FINISH LEGEND	
	TL5
PLAN LEGEND	
	EXISTING CONSTRUCTION
	MILL WORK
	MARBLE COUNTERTOP
	NEW CONSTRUCTION

DESIGNER IDENTIFICATION:

GE BAI

SCAD  
1600 Peachtree Rd NW,  
Atlanta, GA 30309

PHONE: 404-719-0885  
E-MAIL: gebai20@student.scad.edu

PROJECT IDENTIFICATION:

CANTERBURY COURT

3750 Peachtree Rd NE,  
Atlanta, GA 30319

CLIENT IDENTIFICATION:

Mr./Mrs. Kapoor

Canterbury Court  
End Unit Apartment

PROJECT AREA: Residential Unit

DRAWN BY: Ge Bai

CHECKED BY: Prof. Challie Schafer

DATE: May 20, 2020

COURSE #: INDS 714-A02

COURSE NAME: Grad Interior Design Studio II

PROFESSOR: Prof. Challie Schafer

QUARTER: SPRING 2020

KEY PLAN:

PROJECT NAME: Senior Living Assisted Living Unit

SHEET SIZE: 11" x 17"



SHEET SCALE: 1/2"= 1'-0"

SHEET TITLE: ENLARGED KITCHEN PLAN

PLAN NORTH:

ID-201



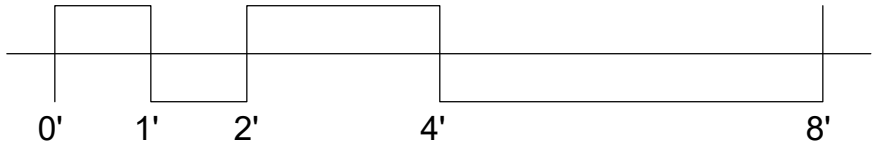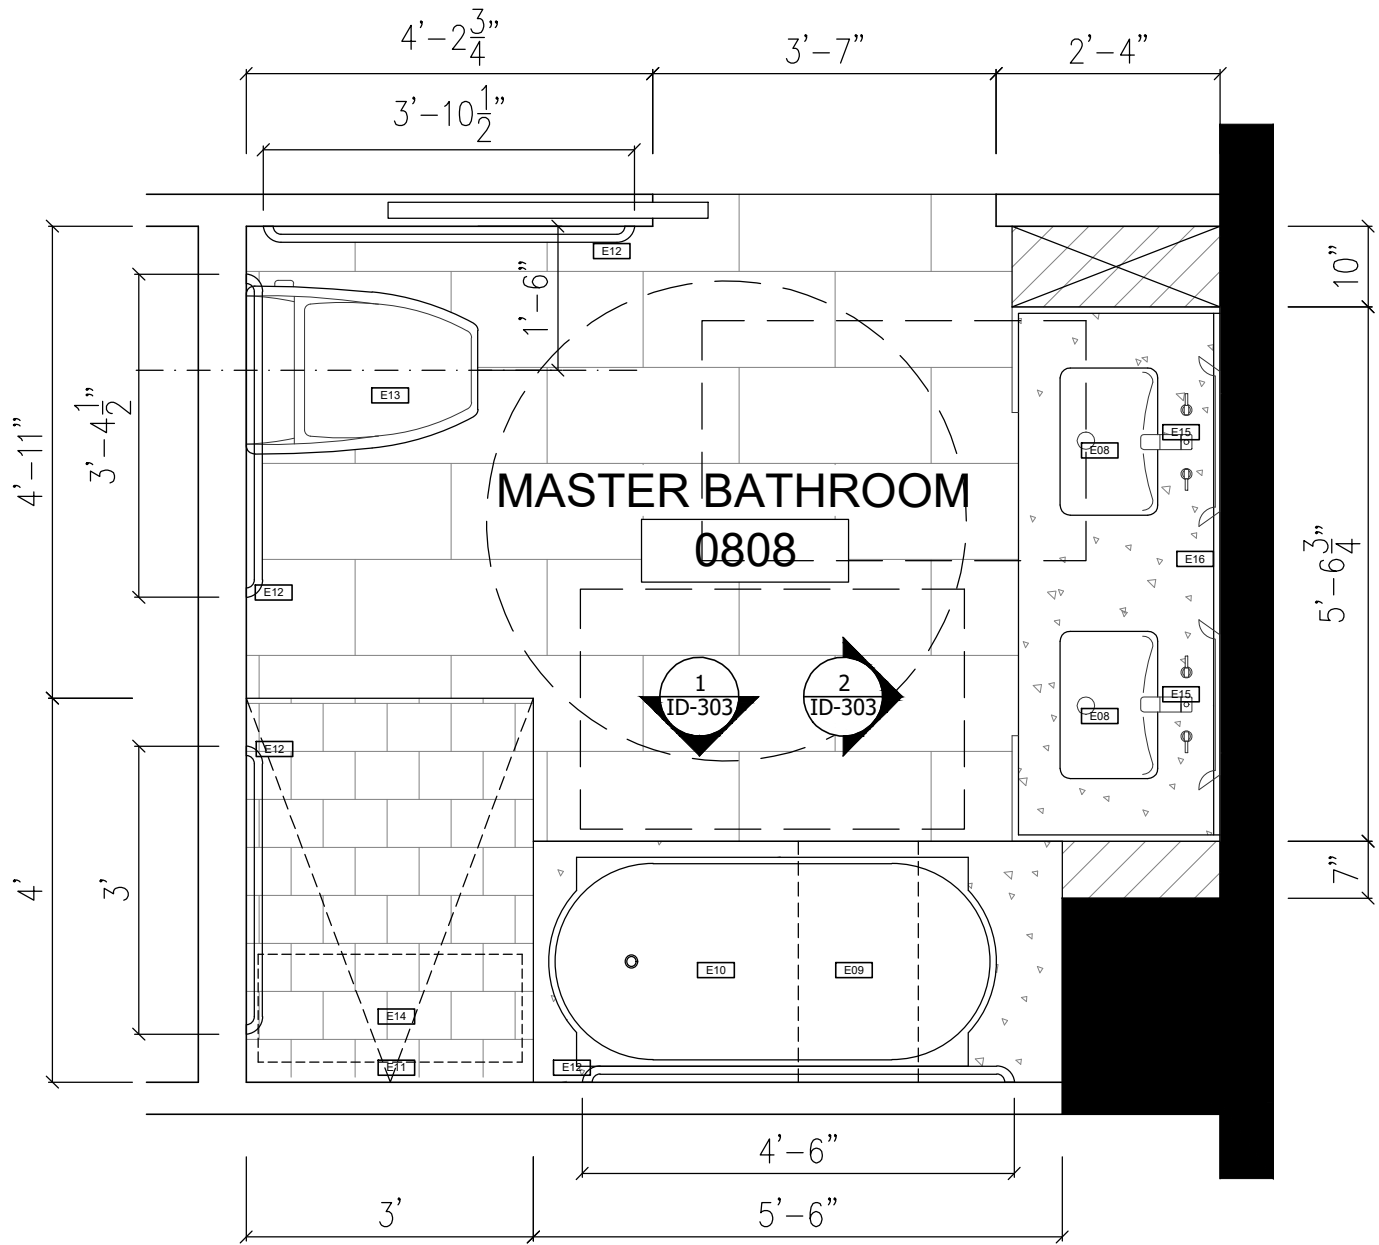

GENERAL NOTES

- 1. Refer to ID-001 graphic symbols.
- 2. Refer to ID-001 equipment schedule.
- 3. Refer to ID-001 flooring schedule.
- 4. TL1 to be 12"x12" unless mentioned otherwise.
- 5. TL3 to be 12"x24" unless mentioned otherwise.
- 6. Refer to ID-303.

FLOOR FINISH LEGEND

	TL1
	TL3

PLAN LEGEND

	EXISTING CONSTRUCTION
	MILL WORK
	MARBLE COUNTERTOP
	NEW CONSTRUCTION

DESIGNER IDENTIFICATION:

GE BAI

SCAD  
1600 Peachtree Rd NW,  
Atlanta, GA 30309

PHONE: 404-719-0885  
E-MAIL: gebai20@student.scad.edu

PROJECT IDENTIFICATION:

CANTERBURY  
COURT

3750 Peachtree Rd NE,  
Atlanta, GA 30319

CLIENT IDENTIFICATION:

Mr./Mrs. Kapoor

Canterbury Court  
End Unit Apartment

PROJECT AREA: Residential Unit

DRAWN BY: Ge Bai

CHECKED BY: Prof. Challie Schafer

DATE: May 20, 2020


COURSE #: INDS 714-A02

COURSE NAME: Grad Interior Design Studio II

PROFESSOR: Prof. Challie Schafer

QUARTER: SPRING 2020

KEY PLAN:

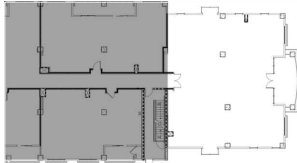

PROJECT NAME: Senior Living Assisted Living Unit  
SHEET SIZE: 11" x 17"  
SHEET SCALE: 1/2"= 1'-0"  
SHEET TITLE: ENLARGED MASTER BATH PLAN

PLAN NORTH:







 
ID-202



GENERAL NOTES

1. Provide a level 5 finish in all areas where wall covering occur. Prefer to finish plan for wall covering location.
2. Tile start point and grout alignments to match finish plans.
3. All baseboard finishes to be WD1 9" as per ADA compliancy unless noted otherwise.
4. Refrigerator, oven, microwave, cooktop, and range hold to be built inside cabinets.

WALL FINISH LEGEND

	WD1
	WD2
	MB1
	PT1
	TL7

WALL SCHEDULE

WD1 | WOOD

Manufacture: British Hardwoods

Profile Style: Scotia

Species: American Black Walnut

WD2 | WOOD

Manufacture: British Hardwoods

Species: Canadian Maple

MB1 | MARBLE

Manufacture: Floor Decor

Product Number: 100427707

Color Name: Fantasy Brown

PT1 | PAINT

Manufacture: Sherwin-Williams

Product Number: SW 7004

Color Name: Snowbound


TL7 | TILE

Manufacture: Stone Impressions

Pattern: Fiore

Color Name: Arctic White

ELEVATION 1

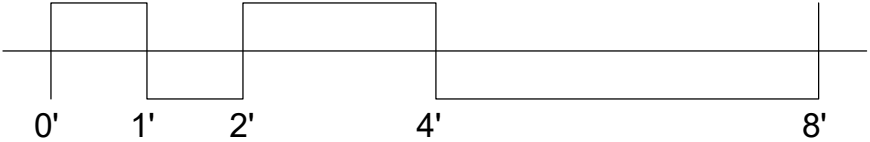

DESIGNER IDENTIFICATION:

GE BAI

SCAD  
1600 Peachtree Rd NW,  
Atlanta, GA 30309

PHONE: 404-719-0885  
E-MAIL: gebai20@student.scad.edu

PROJECT IDENTIFICATION:

CANTERBURY  
COURT

3750 Peachtree Rd NE,  
Atlanta, GA 30319


CLIENT IDENTIFICATION:

Mr./Mrs. Kapoor

Canterbury Court  
End Unit Apartment

PROJECT AREA:	Residential Unit
DRAWN BY:	Ge Bai
CHECKED BY:	Prof. Challie Schafer
DATE:	May 20, 2020
COURSE #:	INDS 714-A02
COURSE NAME:	Grad Interior Design Studio II
PROFESSOR:	Prof. Challie Schafer
QUARTER:	SPRING 2020

KEY PLAN:

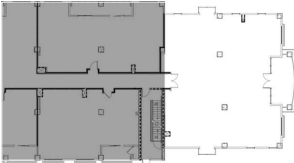

PROJECT NAME: Senior Living Assisted Living Unit  
SHEET SIZE: 11" x 17"  
SHEET SCALE: 1/2"= 1'-0"  
SHEET TITLE: KITCHEN ELEVATIONS

PLAN NORTH:







ID-301



GENERAL NOTES

1. Provide a level 5 finish in all areas where wall covering occur. Prefer to finish plan for wall covering location.
2. Tile start point and grout alignments to match finish plans.
3. All baseboard finishes to be WD1 9" as per ADA compliancy unless noted otherwise.

WALL FINISH LEGEND

	WD1
	WD2
	MB1
	PT1

WALL SCHEDULE

WD1 | WOOD  
Manufacture: British Hardwoods  
Profile Style: Scotia  
Species: American Black Walnut

WD2 | WOOD  
Manufacture: British Hardwoods  
Species: Canadian Maple

MB1 | MARBLE  
Manufacture: Floor Decor  
Product Number: 100427707  
Color Name: Fantasy Brown

PT1 | PAINT  
Manufacture: Sherwin-Williams  
Product Number: SW 7004  
Color Name: Snowbound

DESIGNER IDENTIFICATION:

GE BAI

SCAD  
1600 Peachtree Rd NW,  
Atlanta, GA 30309

PHONE: 404-719-0885  
E-MAIL: gebai20@student.scad.edu

PROJECT IDENTIFICATION:

CANTERBURY  
COURT

3750 Peachtree Rd NE,  
Atlanta, GA 30319


CLIENT IDENTIFICATION:

Mr./Mrs. Kapoor

Canterbury Court  
End Unit Apartment

PROJECT AREA:	Residential Unit
DRAWN BY:	Ge Bai
CHECKED BY:	Prof. Challie Schafer
DATE:	May 20, 2020
COURSE #:	INDS 714-A02
COURSE NAME:	Grad Interior Design Studio II
PROFESSOR:	Prof. Challie Schafer
QUARTER:	SPRING 2020

KEY PLAN:

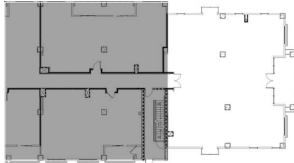


PROJECT NAME: Senior Living Assisted Living Unit  
SHEET SIZE: 11" x 17"  
SHEET SCALE: 1/2"= 1'-0"  
SHEET TITLE: KITCHEN ELEVATIONS

PLAN NORTH:



ID-302

ELEVATION 2

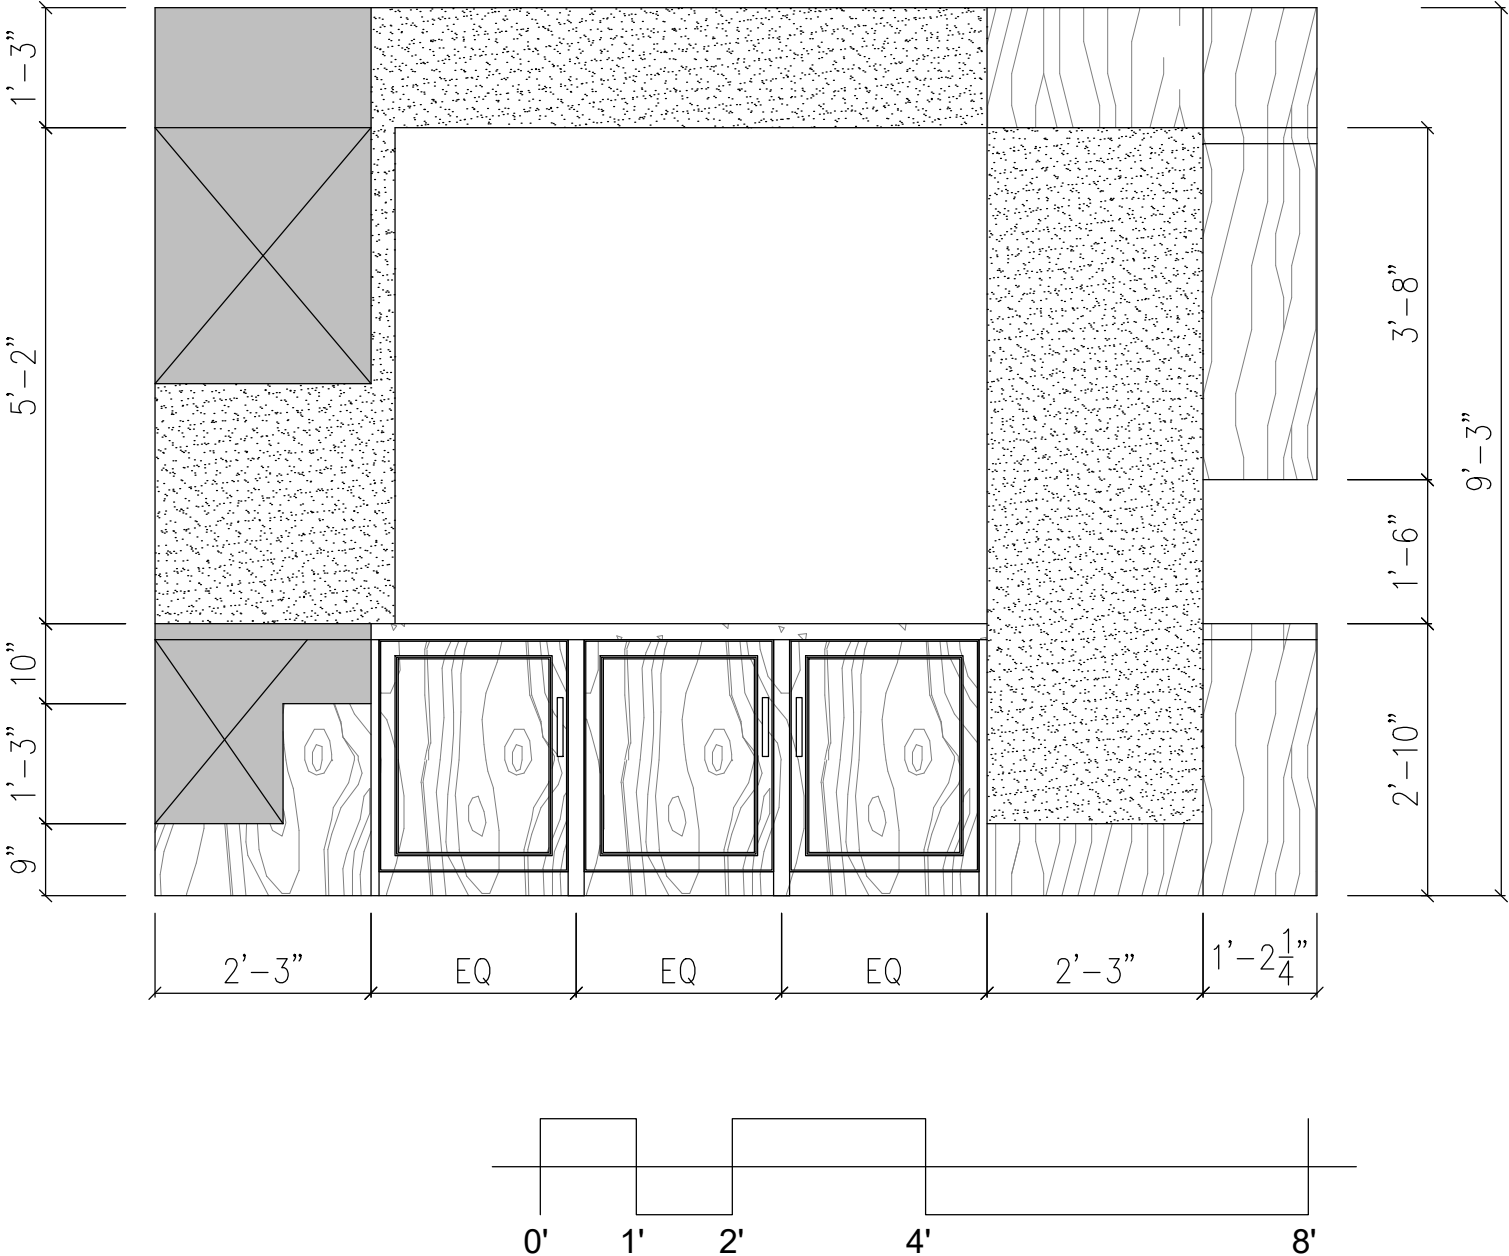



GENERAL NOTES

1. Provide a level 5 finish in all areas where wall covering occur. Prefer to finish plan for wall covering location.
2. Tile start point and grout alignments to match finish plans.
3. All baseboard finishes to be WD1 9" as per ADA compliancy unless noted otherwise.

WALL FINISH LEGEND

	WD1
	TL1
	MB1
	PT1
	TL6

WALL SCHEDULE

WD1 | WOOD  
Manufacture: British Hardwoods  
Profile Style: Scotia  
Species: American Black Walnut

TL1 | TILE  
Manufacture: Elite Tile  
Product Number: OVS1063  
Color Name: Orange

TL6 | TILE  
Manufacture: Daltile  
Product Number: 302575146  
Color Name: Bright White

MB1 | MARBLE  
Manufacture: Floor Decor  
Product Number: 100427707  
Color Name: Fantasy Brown

PT1 | PAINT  
Manufacture: Sherwin-Williams  
Product Number: SW 7004  
Color Name: Snowbound

DESIGNER IDENTIFICATION:

GE BAI

SCAD  
1600 Peachtree Rd NW,  
Atlanta, GA 30309

PHONE: 404-719-0885  
E-MAIL: gebai20@student.scad.edu

PROJECT IDENTIFICATION:

CANTERBURY  
COURT

3750 Peachtree Rd NE,  
Atlanta, GA 30319


CLIENT IDENTIFICATION:

Mr./Mrs. Kapoor

Canterbury Court  
End Unit Apartment

PROJECT AREA:	Residential Unit
DRAWN BY:	Ge Bai
CHECKED BY:	Prof. Challie Schafer
DATE:	May 20, 2020
COURSE #:	INDS 714-A02
COURSE NAME:	Grad Interior Design Studio II
PROFESSOR:	Prof. Challie Schafer
QUARTER:	SPRING 2020

KEY PLAN:

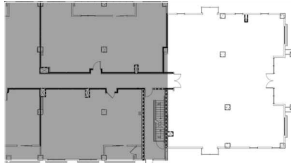


PROJECT NAME: Senior Living Assisted Living Unit  
SHEET SIZE: 11" x 17"  
SHEET SCALE: 1/2"= 1'-0"  
SHEET TITLE: MASTER BATH ELEVATIONS

PLAN NORTH:



ID-303

ELEVATION 1

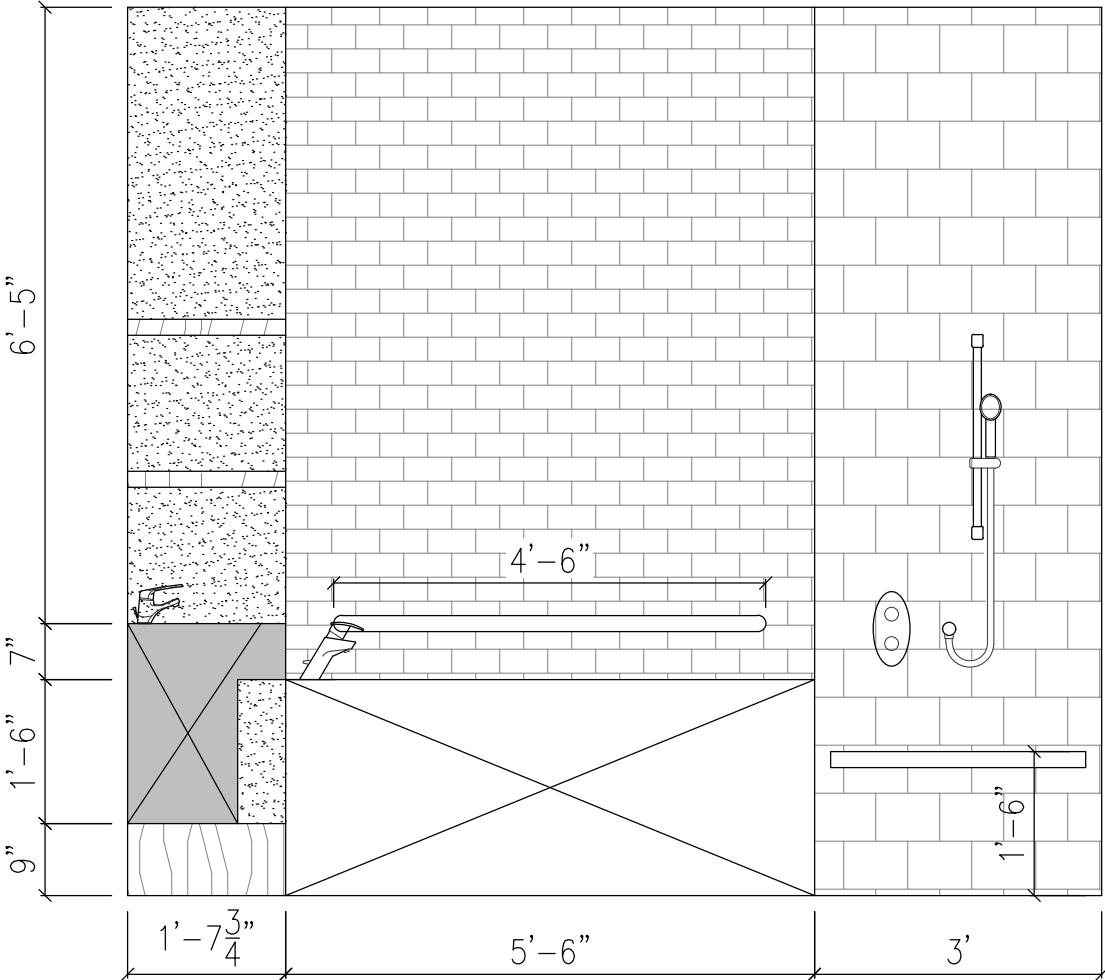

ELEVATION 2

